

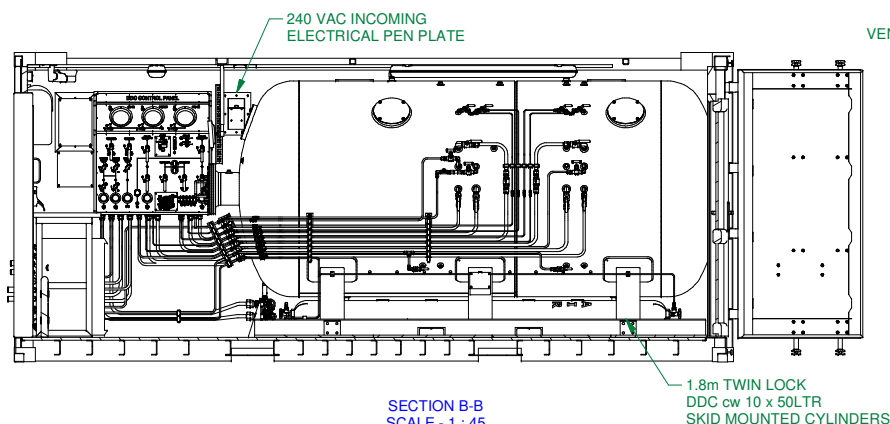
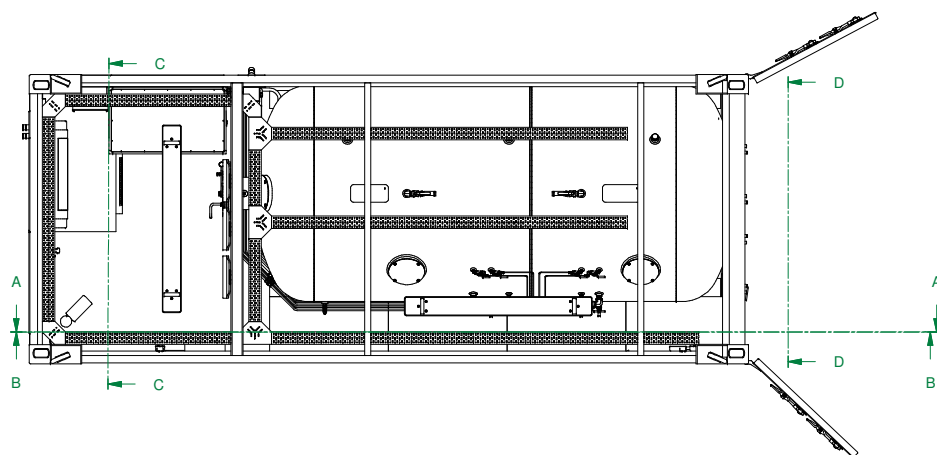
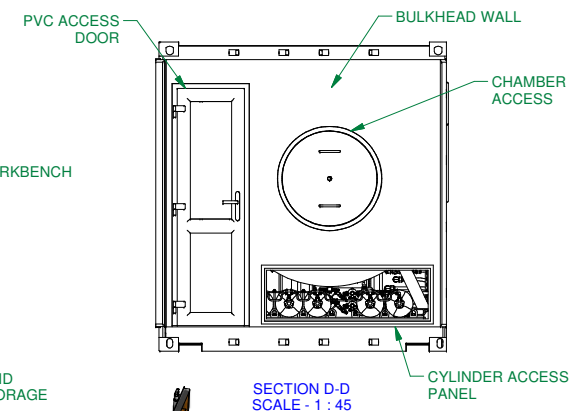
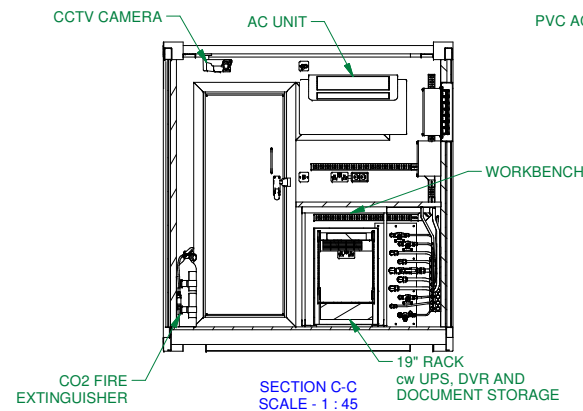


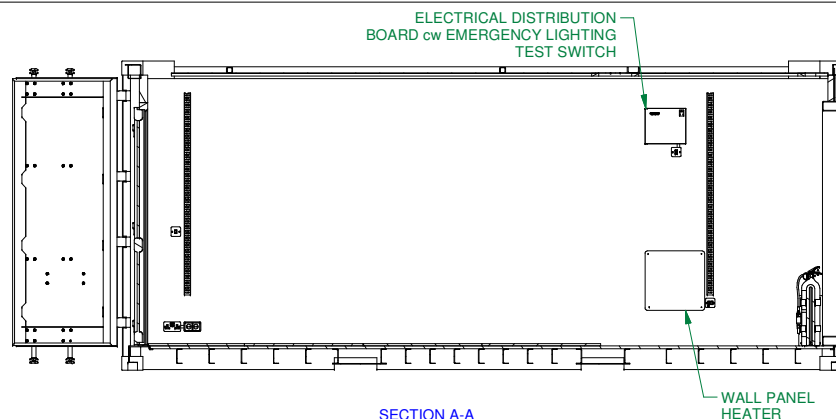

NOTES:

- PART NUMBER - CONTDDC18-07

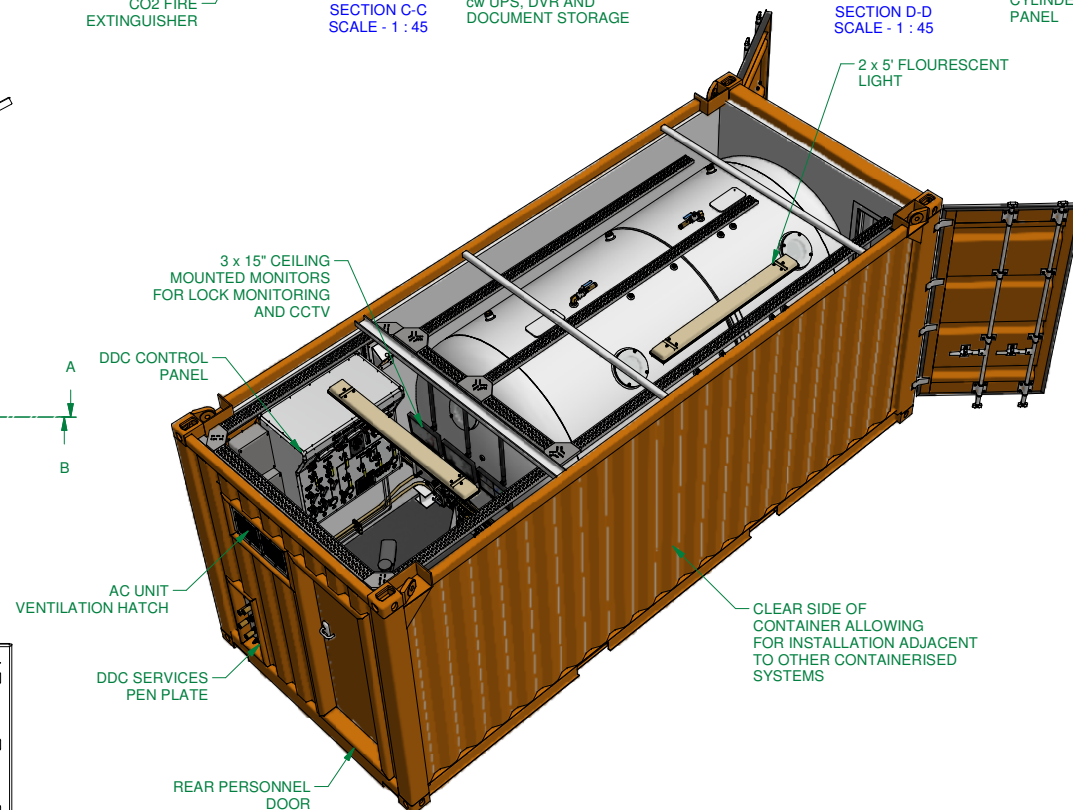


IF IN DOUBT - ASK!

UNLESS OTHERWISE SPECIFIED DIMENSIONS ARE IN MM				
FRACT	X	DECIMALS	XX	ANGLES
1/2	±2	±.40	±.10	±.2°
DO NOT SCALE DRAWING				
DIMENSIONS AND TOLERANCES PER BS 8888 (SUPERSEDES BS308 2000)				


2	09/08/2016	JRoberts	APiksa	ADavies	MECHANICAL & ELECTRICAL LAYOUT UPDATE
1	04/04/2016	JRoberts	APiksa	ADavies	ISSUED FOR CONSTRUCTION
REV	DATE	DRAWN	CHECKED	APPROVED	DESCRIPTION
 Submarine Manufacturing & Products Ltd Blackpool Road, Newton, Preston, Lancashire, PR4 3RE Tel:01772 687775 Fax:01772 687774 www.smp-ltd.co.uk					
TITLE: 20' DNV CONTAINERISED 1.8m DDC cw UNDERSIDE GAS STORAGE - G.A.					
CONTRACT No: -		DWG No: 2112-101		SHEET No: 1 OF 2	
SCALE: 1 : 30		DATE: 01/04/2016		 SIZE: A3 REV: 2	

© THIS DOCUMENT CONTAINS PROPRIETARY INFORMATION OF SUBMARINE MANUFACTURING AND PRODUCTS LTD AND SHALL NOT BE COPIED OR REPRODUCED IN WHOLE OR IN PART FOR ANY PURPOSE WITHOUT THE PRIOR WRITTEN CONSENT.

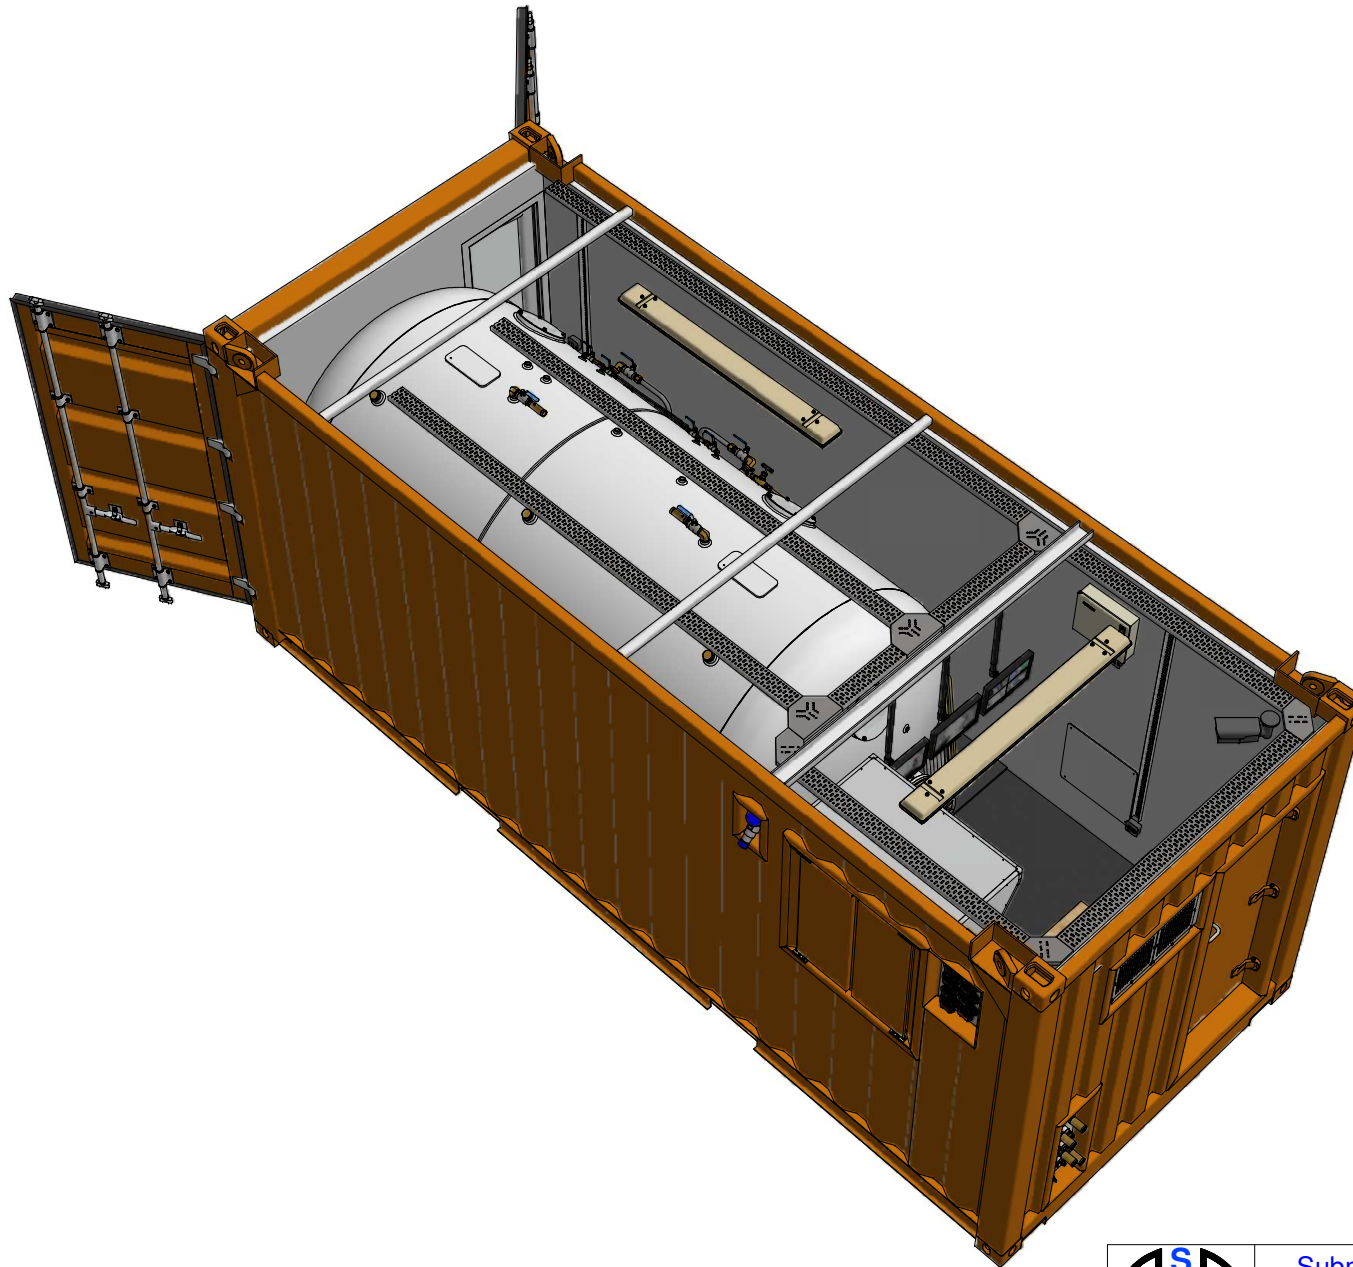

IF IN DOUBT - ASK!

UNLESS OTHERWISE SPECIFIED DIMENSIONS ARE IN MM				
FRACT	DECIMALS			ANGLES
	X	X	XX	
1/2	±2	±.40	±.10	±.2°
DO NOT SCALE DRAWING				
DIMENSIONS AND TOLERANCES PER BS 8888 (SUPERSEDES BS308 2000)				

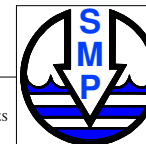

© THIS DOCUMENT CONTAINS
PROPRIETARY INFORMATION OF
SUBMARINE MANUFACTURING AND
PRODUCTS LTD AND SHALL NOT BE
COPIED OR REPRODUCED IN WHOLE OR
IN PART FOR ANY PURPOSE WITHOUT
THE PRIOR WRITTEN CONSENT.

Submarine Manufacturing & Products Ltd

Blackpool Road, Newton, Preston, Lancashire, PR4 3RE

Tel: 01772 687775 Fax: 01772 687774

www.smp-ltd.co.uk

TITLE:
20' DNV CONTAINERISED 1.8m DDC cw UNDERSIDE GAS STORAGE - G.A.

CONTRACT No:	-	DWG No:	2112-101	SHEET No:	2 OF 2
SCALE:	1 : 30	DATE:	01/04/2016	SIZE:	A3
				REV:	2